


REVISIONS			
Rev	by	Date	Comment
*			

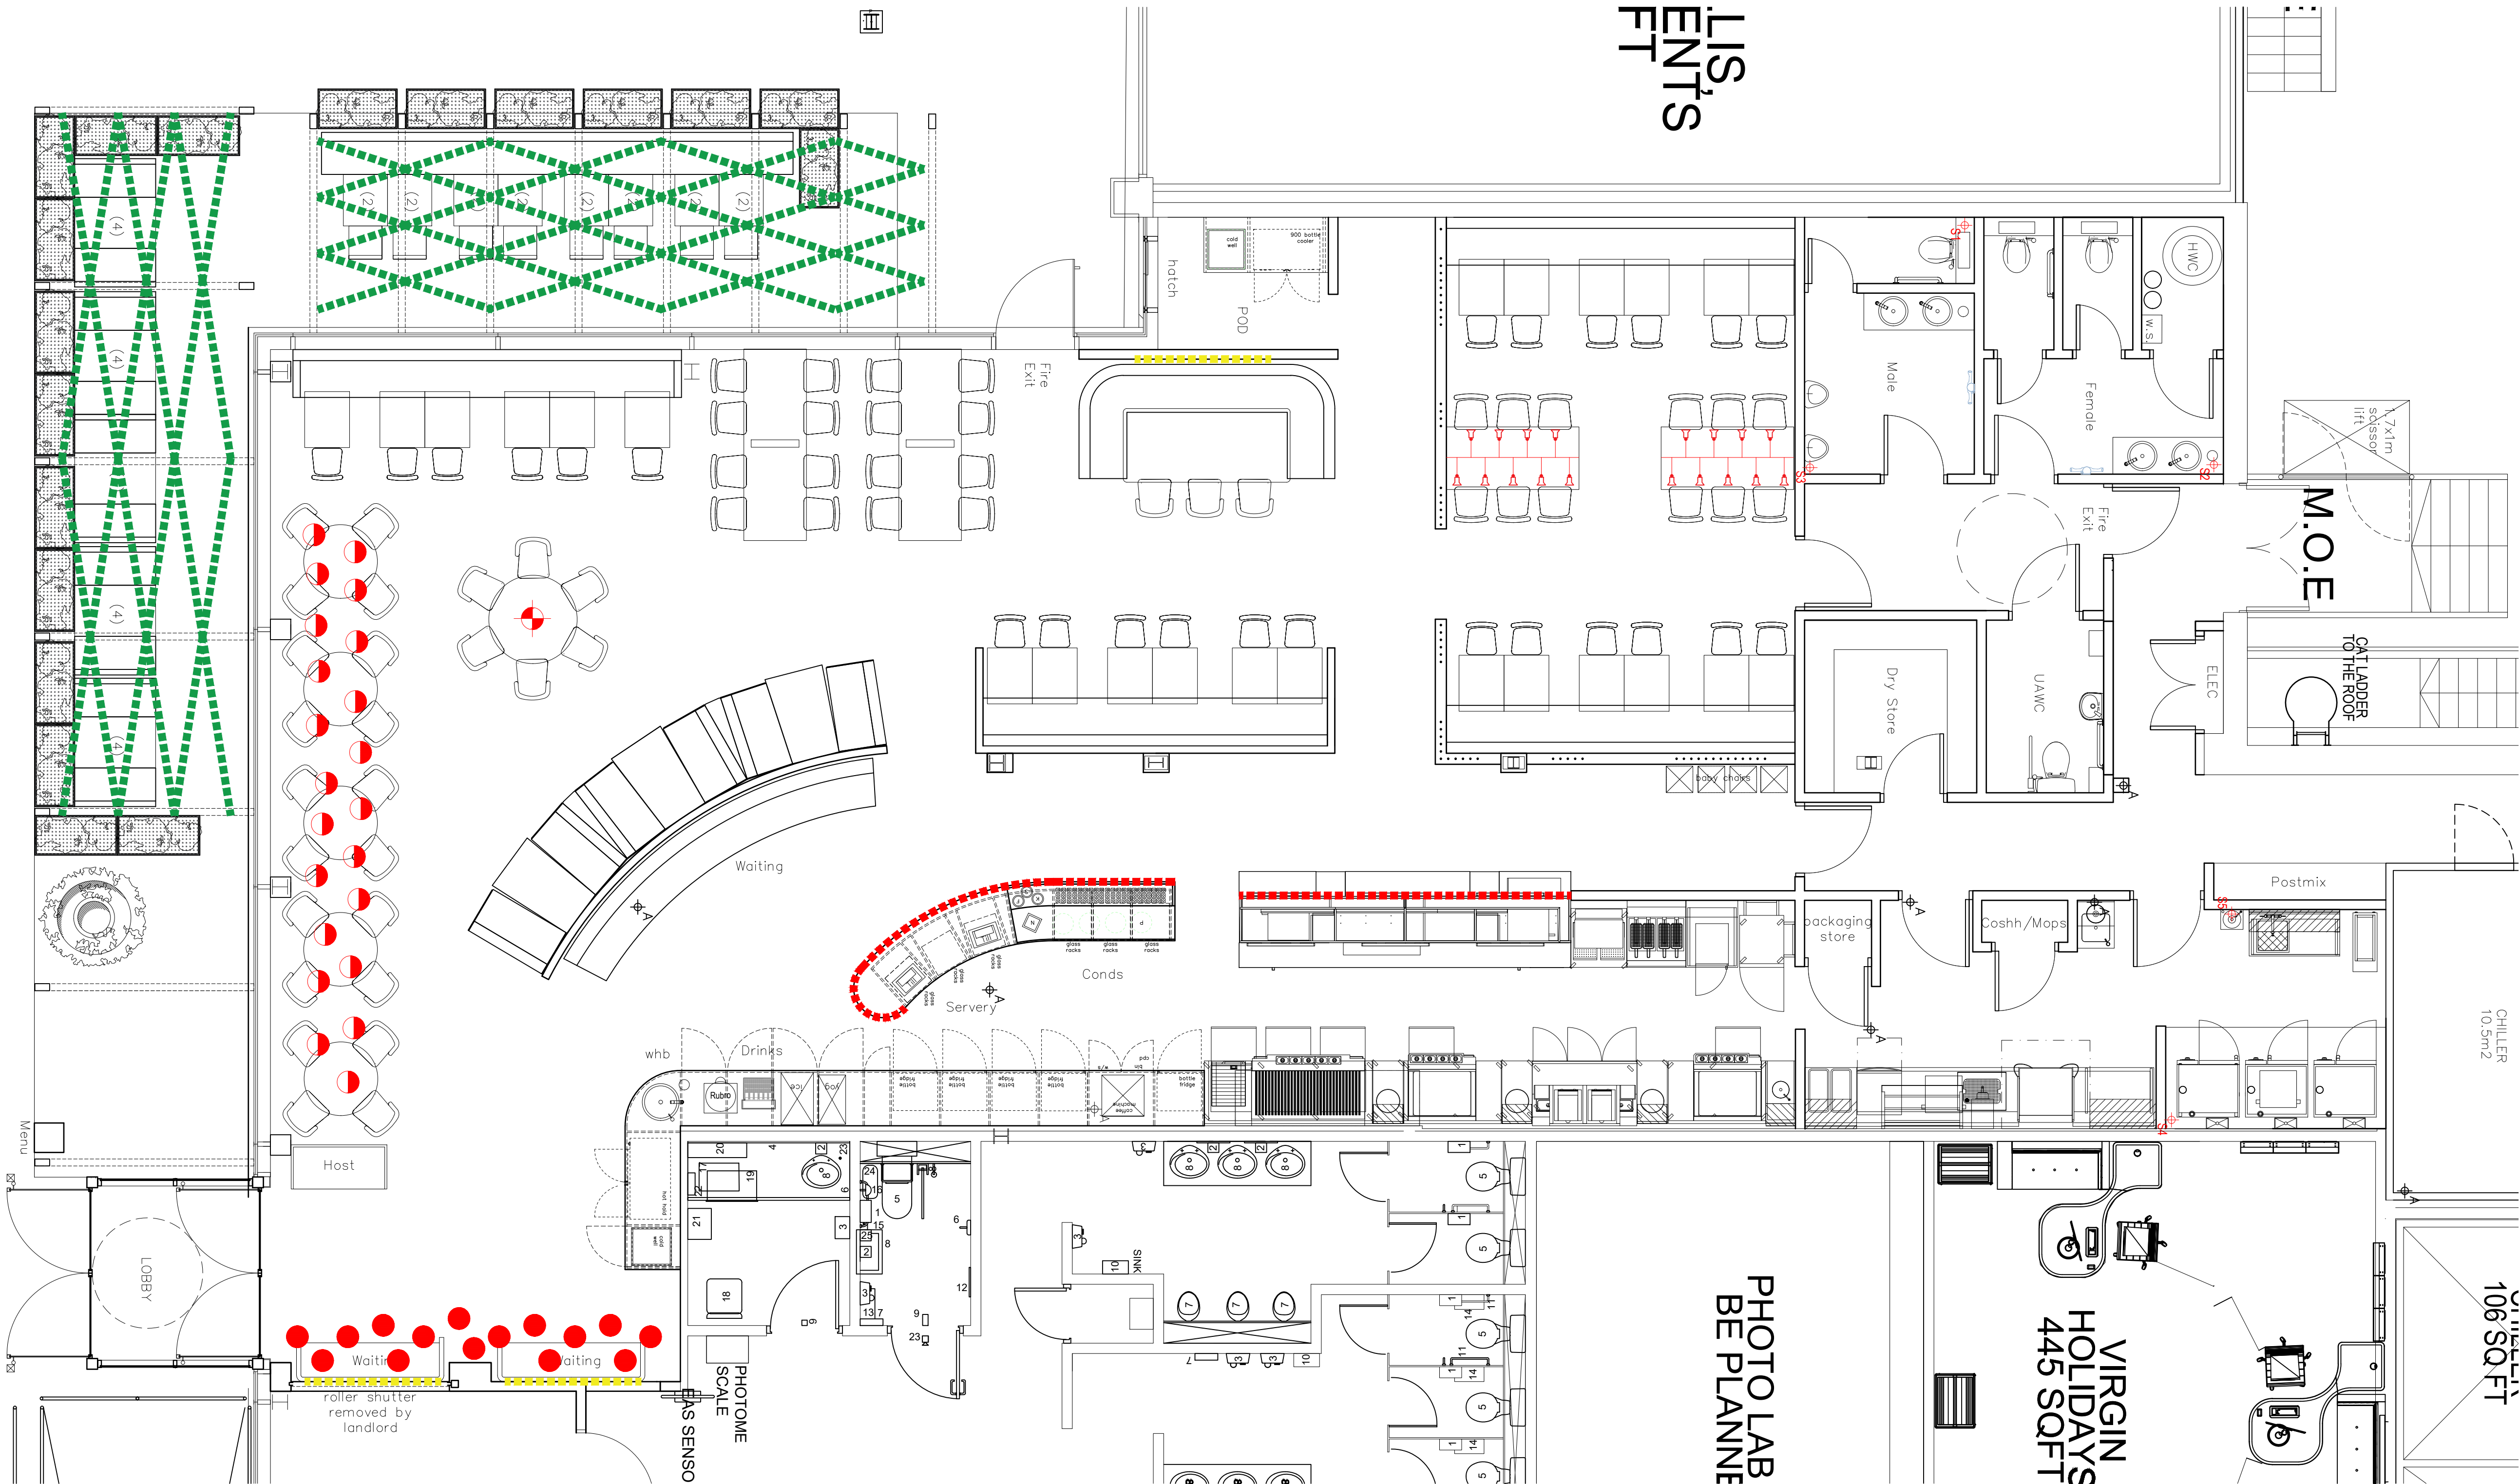

Location Plan
Scale 1:50

REF	IMAGE	SYMBOL	DESCRIPTION	QTY
A			Spec: Handmade Glass pendants (some of them reused from a different site) Supplier: Into Lighting Design	14
B			Spec: 1500 mm dia. Tildi by Ashanti Design Supplier: Nando's Portal / Into Lighting Design	22
C			Spec: Fountain Pendant (Short & Tall) Supplier: Nando's Portal / Into Lighting Design	10
D			Spec: Madola Haywire light 2100 mm in RAL 1032 Supplier: Nando's Portal / Into Lighting Design	2
E			Spec: LED light strips on the servery / condiments units and super co-ordinator Supplier: Into Lighting Design	11 m
F			Spec: LED light strips behind artwork Supplier: Into Lighting Design	20 m
G			Spec: Outdoor festoon lighting Supplier: Into Lighting Design	-

CLIENT

PROJECT

Tesco Extra, Brookfield Centre
Cheshunt
EN8 0TA

TITLE

Decorative Lighting Layout

DRAWN

AL

SCALE @ A1

As stated

DRAWING NO.

4943/11/*

CHECKED

--

DATE

Mar 2022

Harrison.

LONDON
BIRMINGHAM
DALLAS

+44 (0) 20 7046 6556
+44 (0) 121 321 3030
+1972 807 9257