

 



 

 

 





 
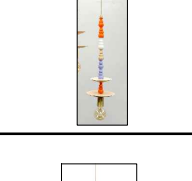
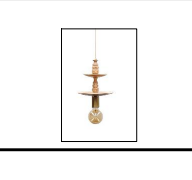


REVISIONS			
Rev	by	Date	Comment
*	HT	28.02.23	FIRST ISSUE

DECORATIVE LIGHTING LEGEND			
REFERENCE	QTY	IMAGE	SPECIFICATION
 P1	2		Nandos Portal Ashanti Mash T Design Studio Tutu 2.2 Shade Dia: 700mm H: 700mm Suspended over U shapes booths
 P2	9		Nandos Portal Ashanti Puka 63 pendant W: 760mm L: 630mm H: 225 mm Pendant shape TBC by supplier Refer to 5177 - 05 Internal Elevations 5177 - 09 Proposed Ceiling Finishes
 P3	6		Nandos Portal Ashanti Fish Basket 400 - with custom yellow dip dye Dia: 500 mm H: 500mm Refer to 5006 - 05 Internal Elevations for drop height required
 P4	6		Nandos Portal Ashanti Bopah Rangl 500 - yellow Dia: 500 mm H: 700mm Refer to 5006 - 05 Internal Elevations for drop height required
 P5	6		Nandos Portal Ashanti Taku - with yellow trim Dia: 450 mm H: TBCmm Refer to 5006 - 05 Internal Elevations for drop height required
 P6	6		Nandos Portal Ashanti Uchim - with yellow spray to bottom section Dia: 740 mm H: 450 mm Refer to 5006 - 05 Internal Elevations for drop height required

REFERENCE	QTY	IMAGE	SPECIFICATION
 P7	6		Nandos Portal Ashanti Samaki 50 - yellow dip to base Dia: 500 mm H: 700mm Refer to 5006 - 05 Internal Elevations for drop height required
 P8	6		Nandos Portal Ashanti Ullil 47 - natural raffia with yellow dip to base Dia: 475 mm H: 400mm Refer to 5006 - 05 Internal Elevations for drop height required
 P9	4		Nandos Portal Modern Gesture Citrus Fountain Pendant - orange & lilac Dia: 200mm H: 570mm
	3		Fountain Pendant - Short Dia: 200mm H: 370mm Refer to 5177 - 05 Internal Elevations for drop height required in shopfront
LED	X		LED Tape Lighting- Warm White By lighting designer

GENERAL NOTES:


Drawing to be read in conjunction with:
5177- 05 Proposed Internal Elevations
5177- 09 Ceiling Finishes
5177- 23 Ceiling Details

Colour rendition to all lights to be warm white (2700K or below).

All FOH circuits to be on multi-channel scene setting dimmer pack. Switching diagram & loadings schedule to be created by lighting supplier or electrical contractor once appointed.

All luminaries to be dimmable led. all BOH lighting to be designed and supplied by local electrical contractor to meet relevant codes of practice.

All emergency light fittings to be recessed, converted decorative fittings - no surface mounted/bulkhead fittings within FOH please!

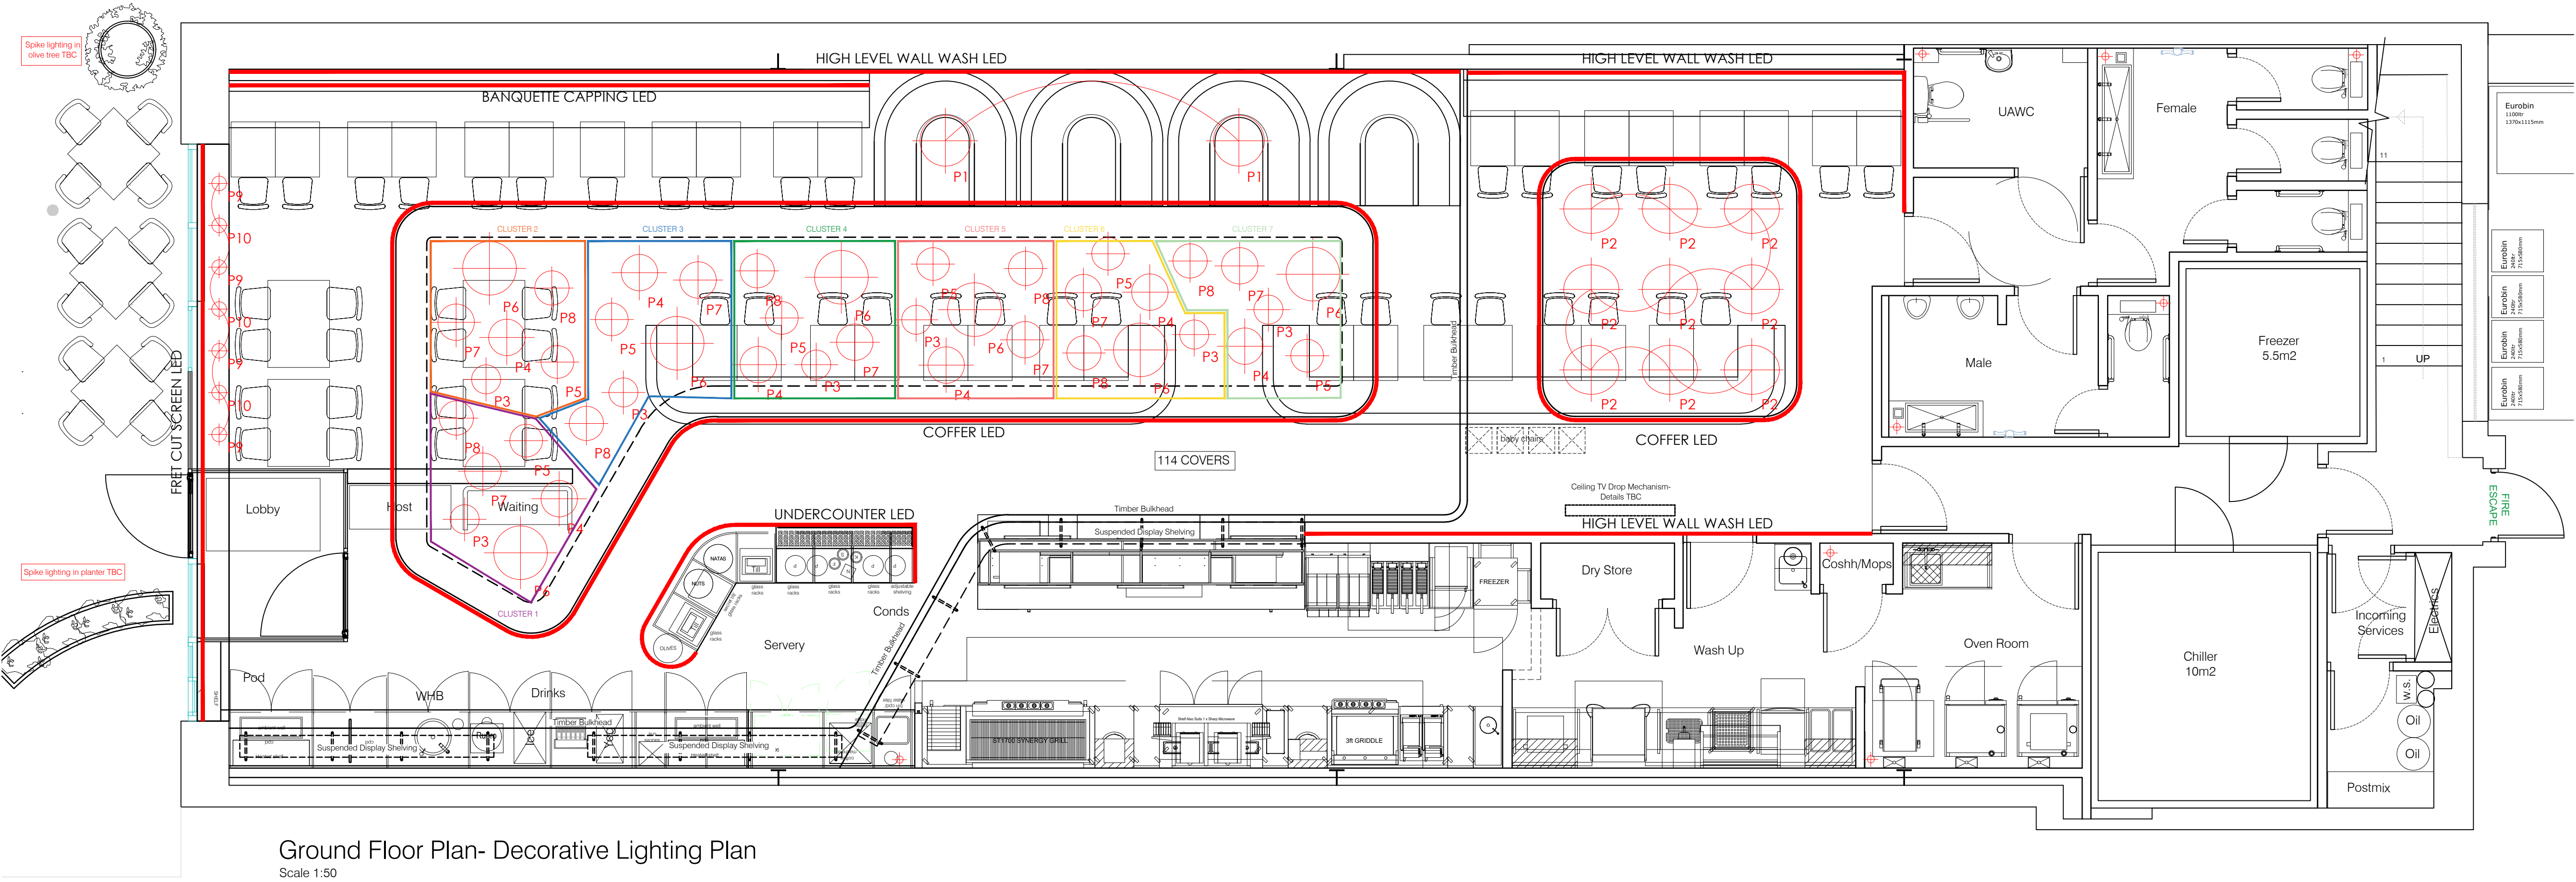

NOTE:
Drawing is design intent for scope and portal fitting identification purposes- refer to lighting designers dwgs (Light Corp) for full specification and layout

CLIENT
Nando's

PROJECT
Unit 11
Craigleith Retail Park, South Groathill Road
Edinburgh EH4 2LN

TITLE
Decorative Lighting Plan

DRAWN	CHECKED
HT	--
SCALE @ A1	DATE
1:50	Sep 2022
DRAWING NO.	
5177/13/*	FOR TENDER

Harrison. LONDON +44 (0) 20 7046 6556
BIRMINGHAM +44 (0) 121 321 3030
DALLAS +1972 807 9257